
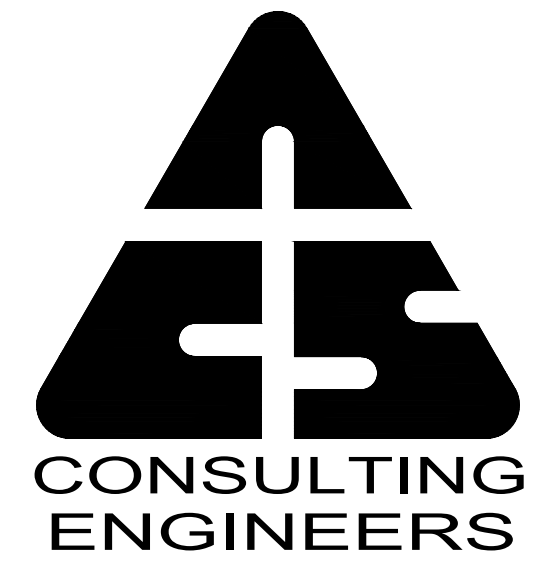


CODE REFERENCE

- 2016 CALIFORNIA BUILDING CODE
- 2016 CALIFORNIA ELECTRIC CODE
- 2016 CALIFORNIA PLUMBING CODE
- 2016 CALIFORNIA MECHANICAL CODE
- 2016 CALIFORNIA RESIDENTIAL CODE
- 2016 CALIFORNIA GREEN BUILDING CODE

DRAWING INDEX

- C-1.0 KEY PLAN
- C-2.0 SITE GRADING PLAN
- C-3.0 SITE DRAINAGE PLAN
- C-4.0 SITE UTILITIES PLAN

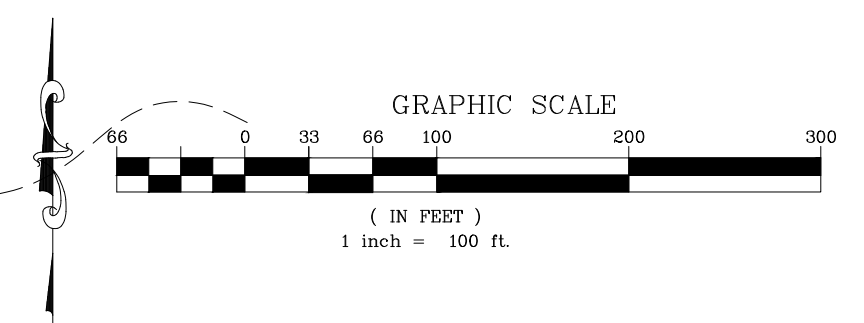


1124 E. 17th Street, #B
San Leandro, California 94577
Tel. (510) 645-1129
Fax. (510) 645-1139



© 2018 ACS CONSULTING ENGINEERS

MONTE VISTA MEMORIAL GARDENS

APN 099-0015-016-03
3656 LAS COLINAS RD.
LIVERMORE, CA 94551

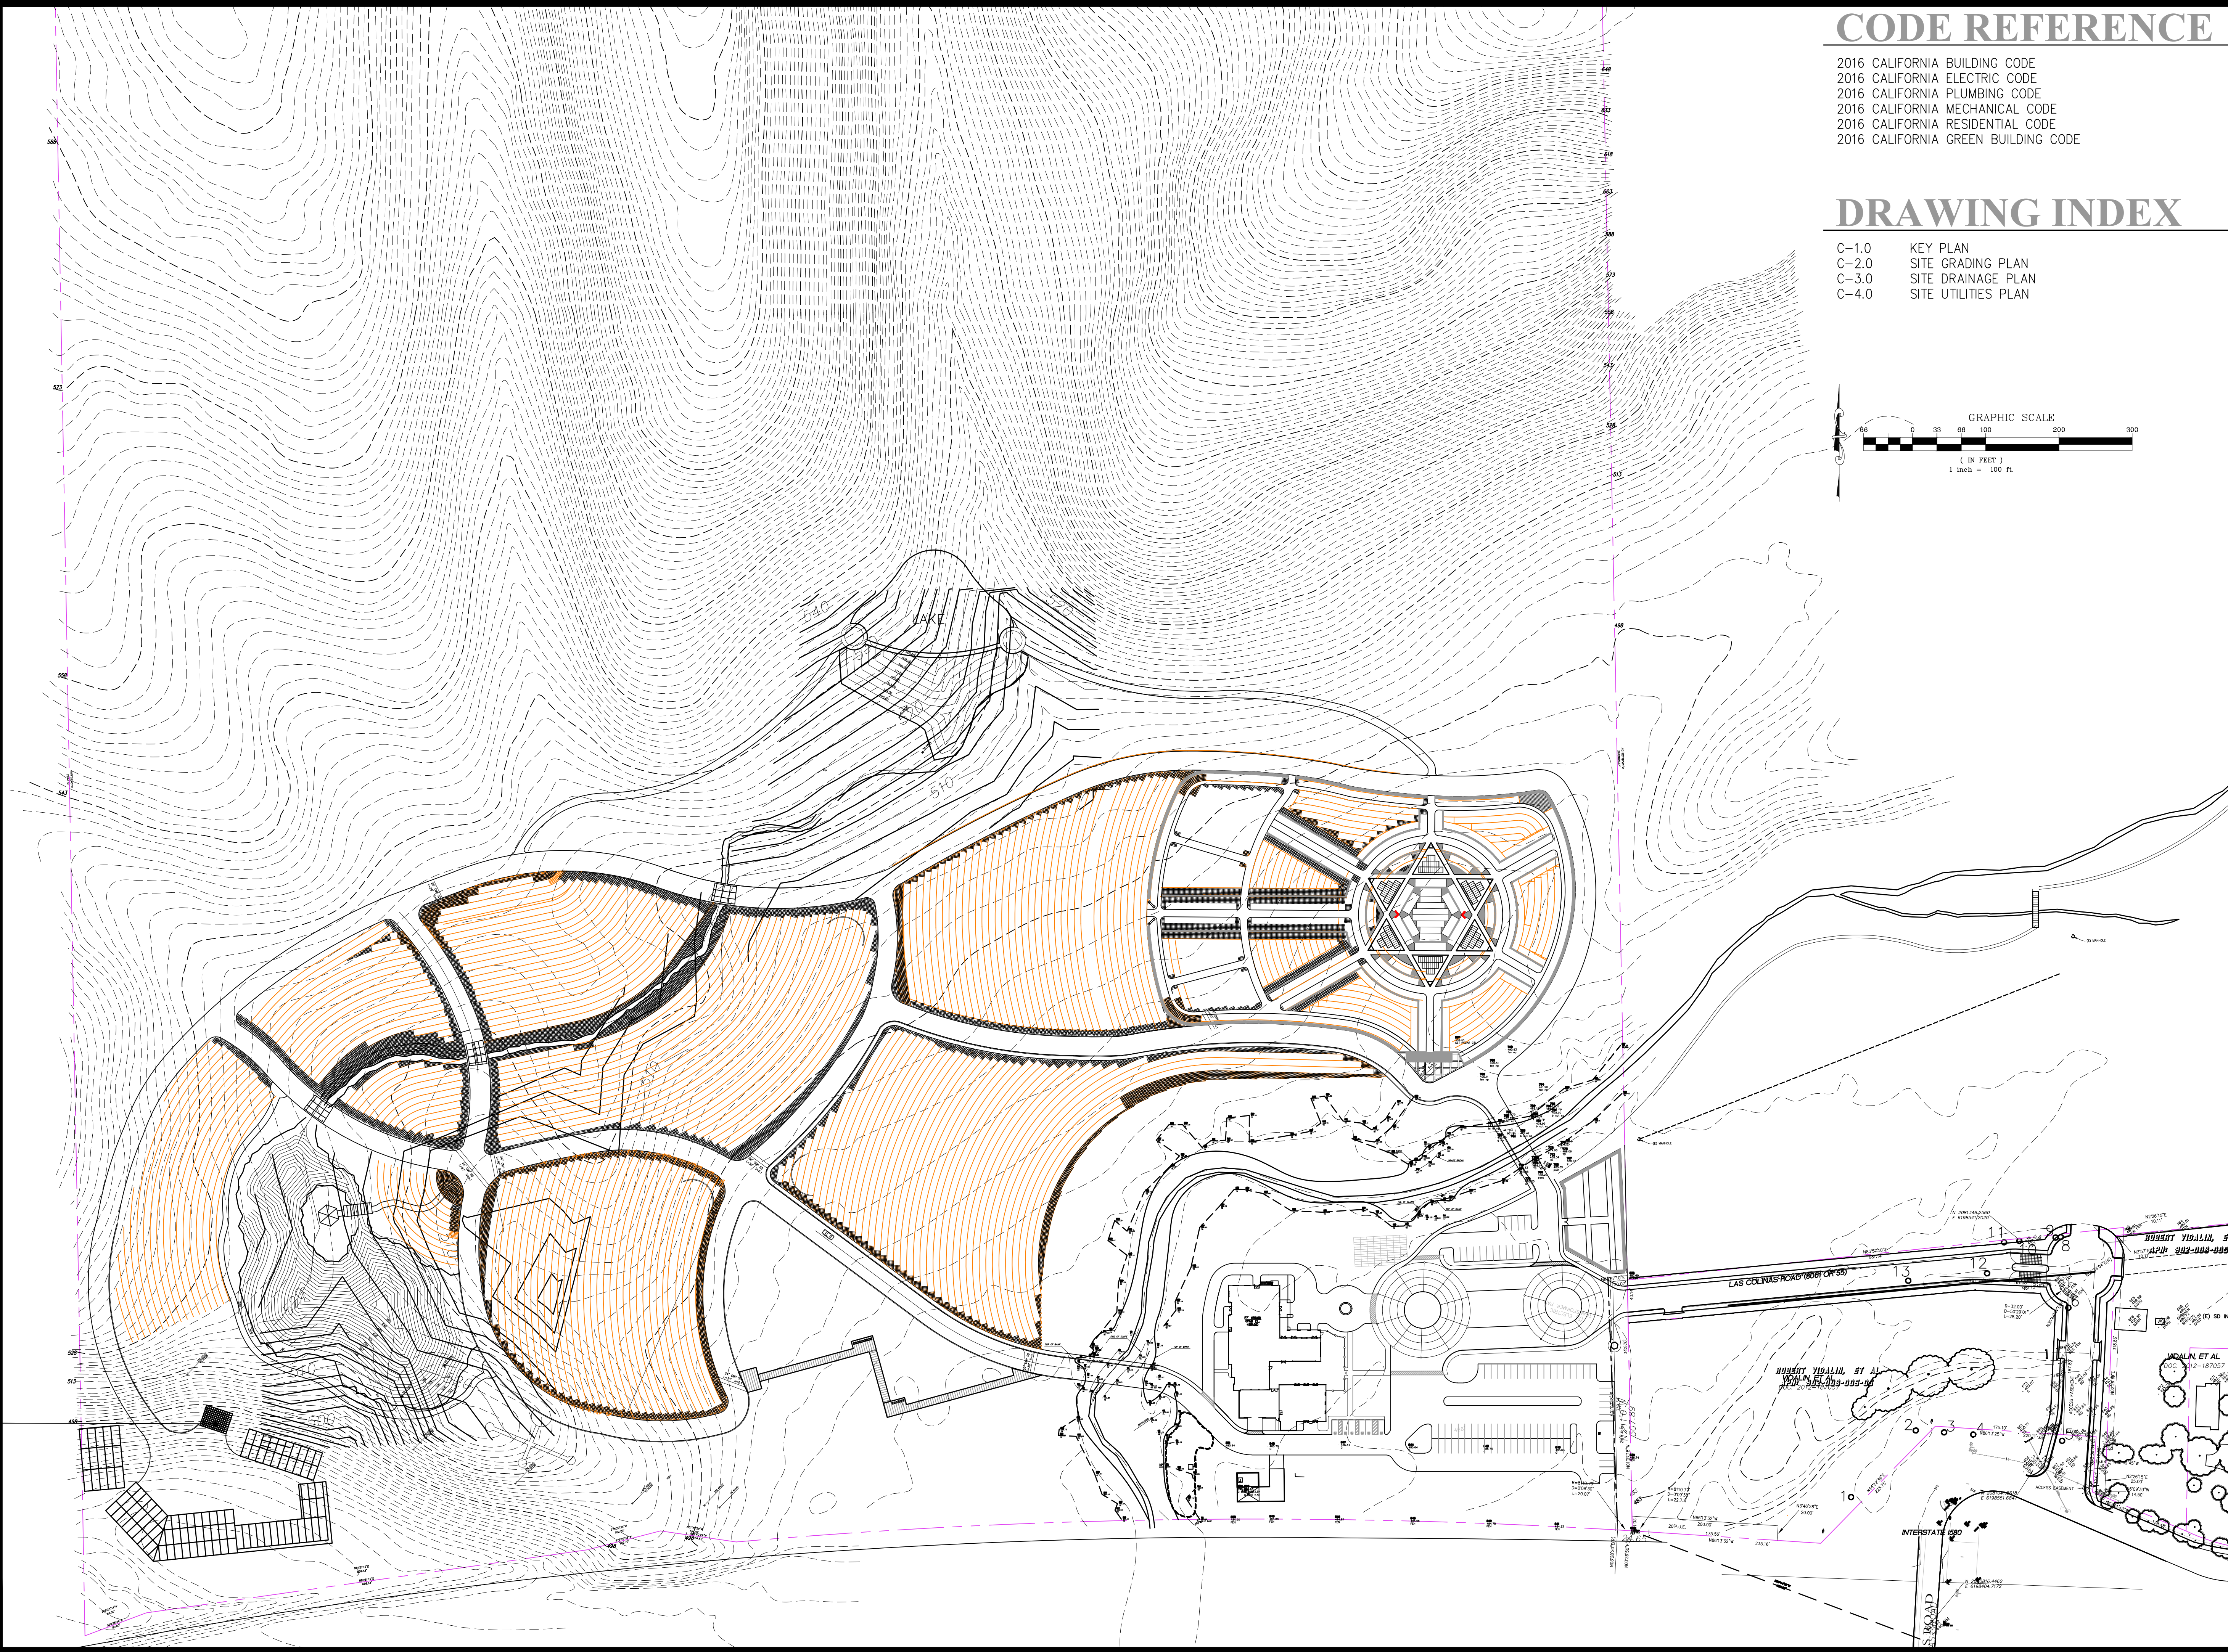

DRAWN BY	CHECKED BY	
VIT	JPA	
NO.	DATE	ISSUE
	05/05/2018	REVIEW SET

SHEET TITLE


KEY SITE PLAN

SCALE: 1" = 100'



SHEET NUMBER

C-1.0

ACS JOB NO.: 18-19026

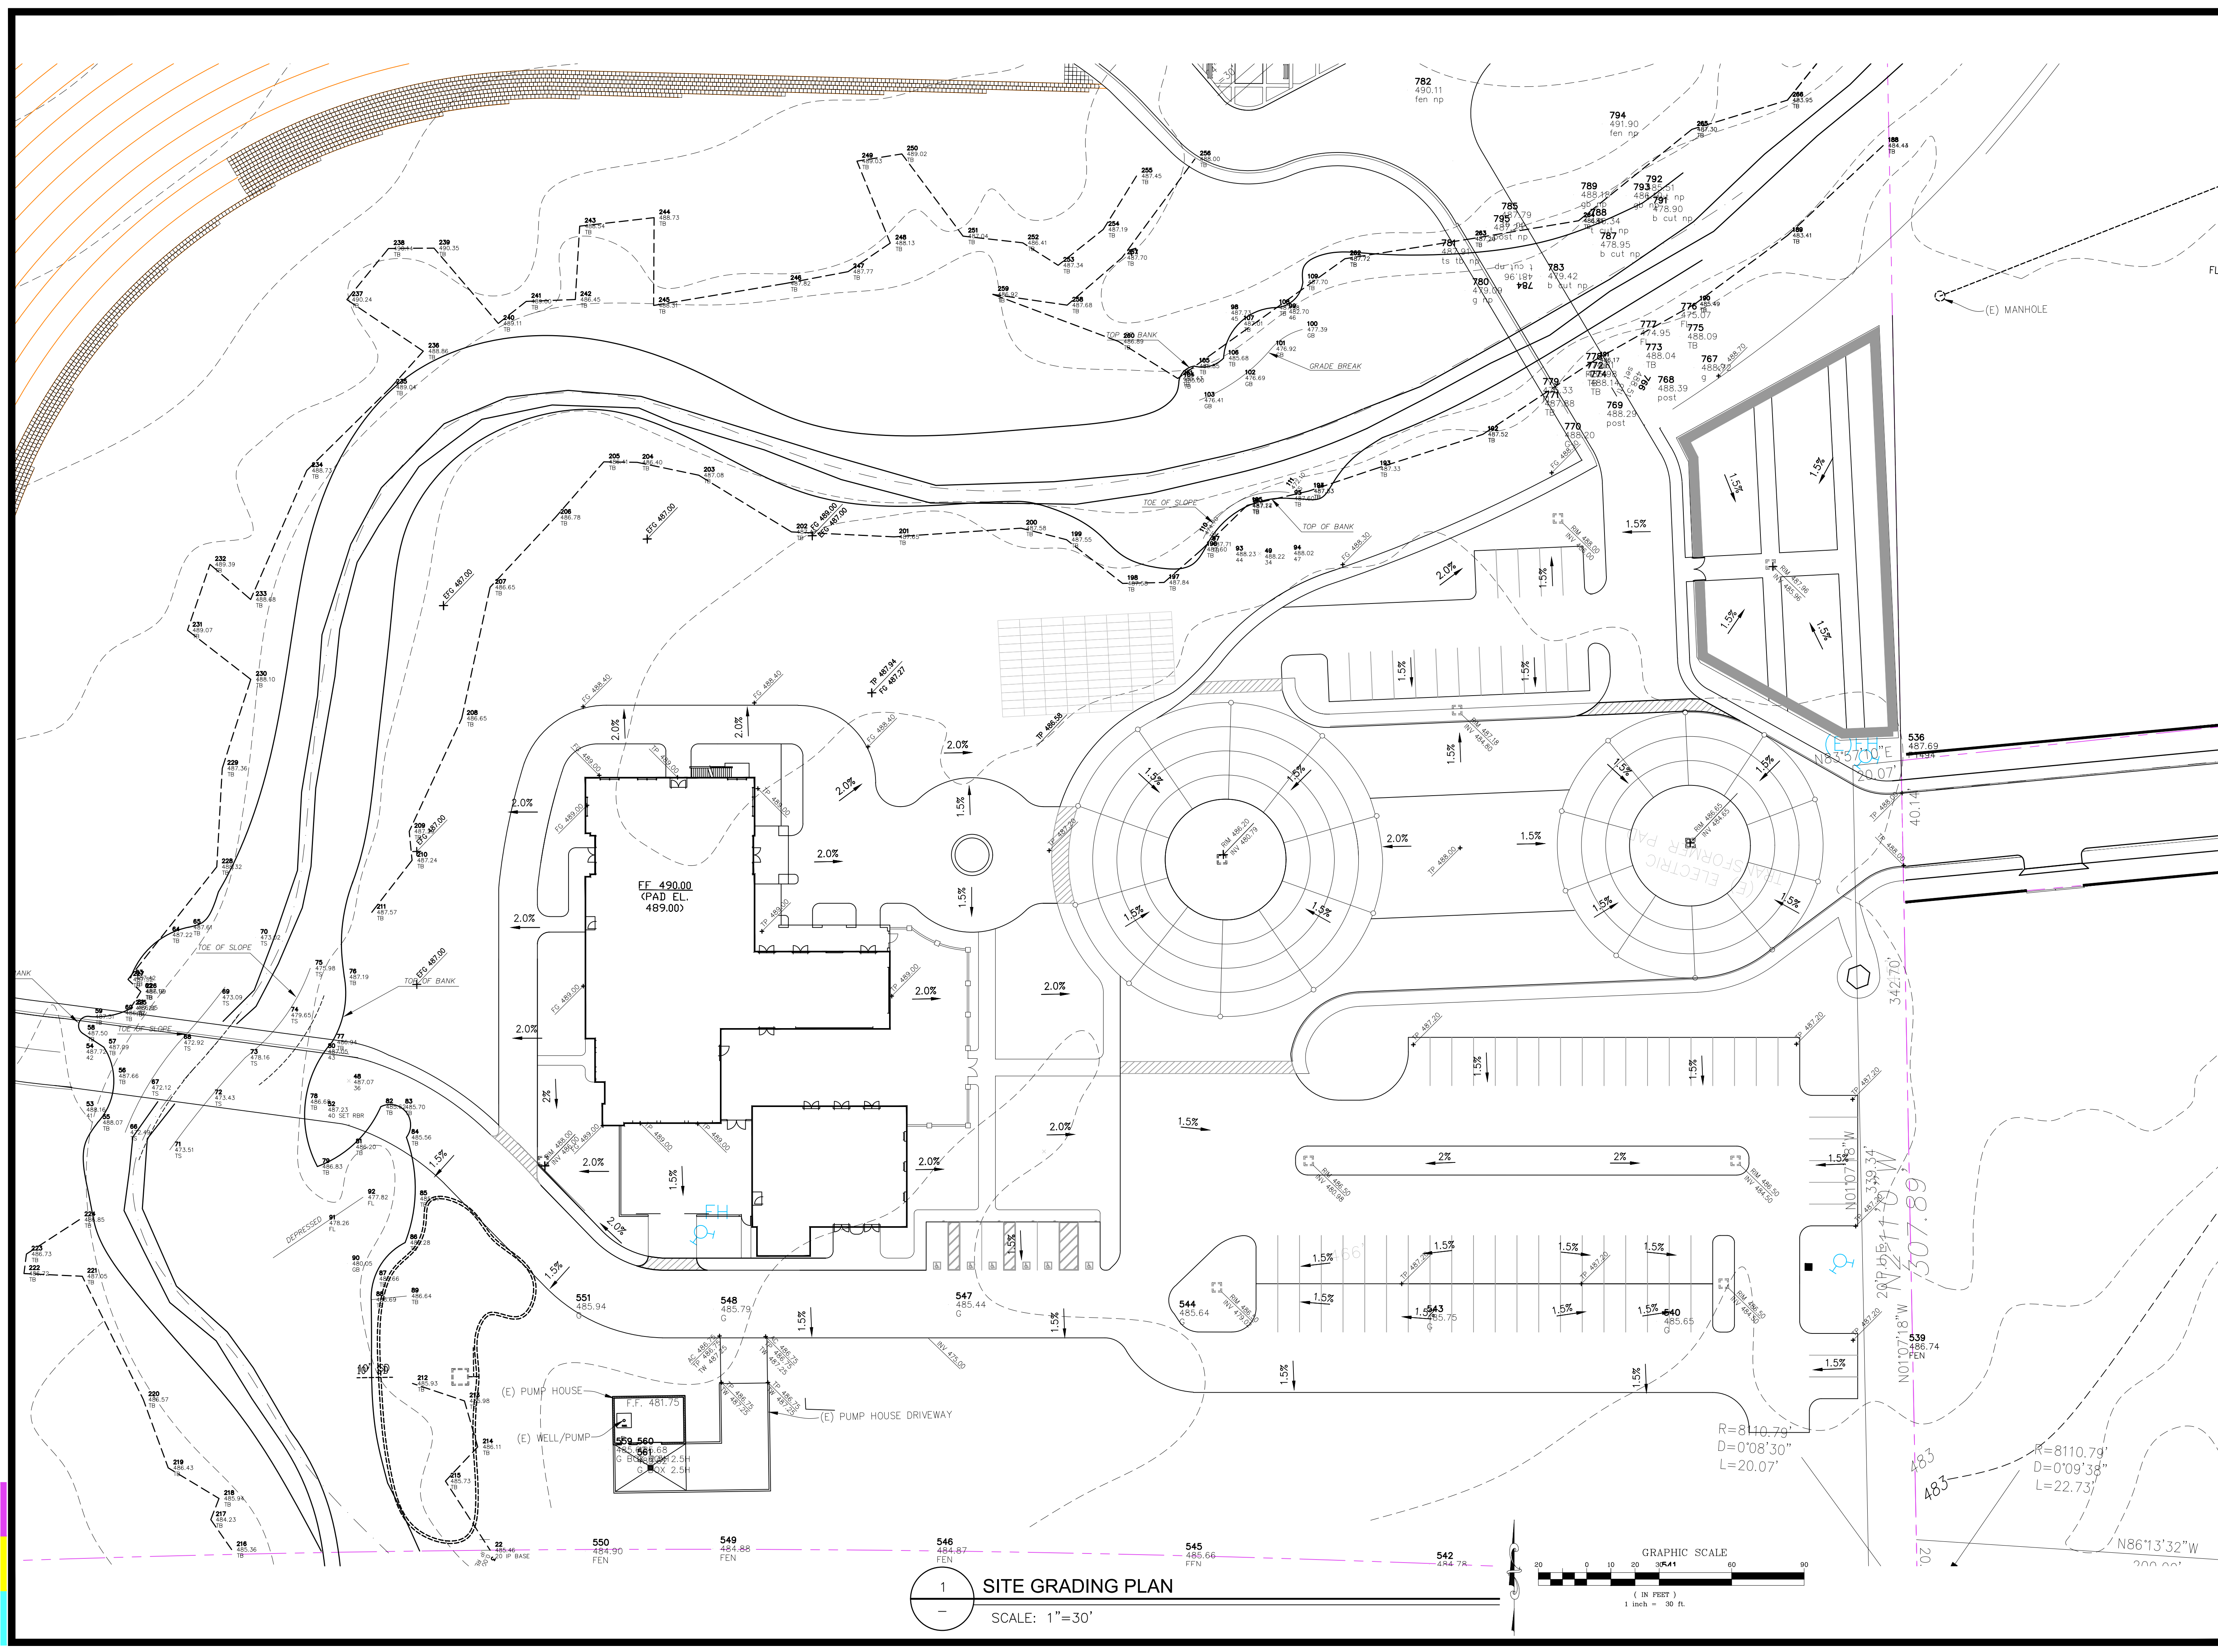

1 SITE GRADING PLAN
SCALE: 1"=30'

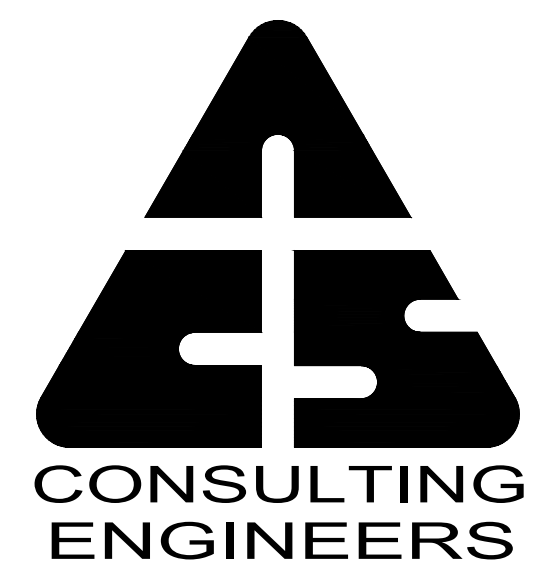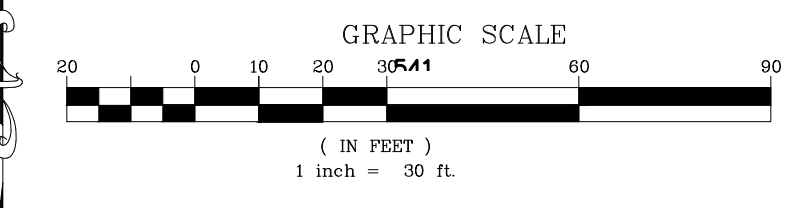

1124 E. 17th Street, #B
San Leandro, California 94577
Tel. (510) 645-1129
Fax. (510) 645-1139



© 2018 ACS CONSULTING ENGINEERS

MONTE VISTA
MEMORIAL GARDENS

APN 099-0015-016-03
3656 LAS COLINAS RD.
LIVERMORE, CA 94551


DRAWN BY	CHECKED BY	
VIT	JPA	
NO.	DATE	ISSUE
	05/05/2018	REVIEW SET

SHEET TITLE
SITE GRADING PLAN



SCALE: AS NOTED
SHEET NUMBER

C-2.0

ACS JOB NO.: 18-19026

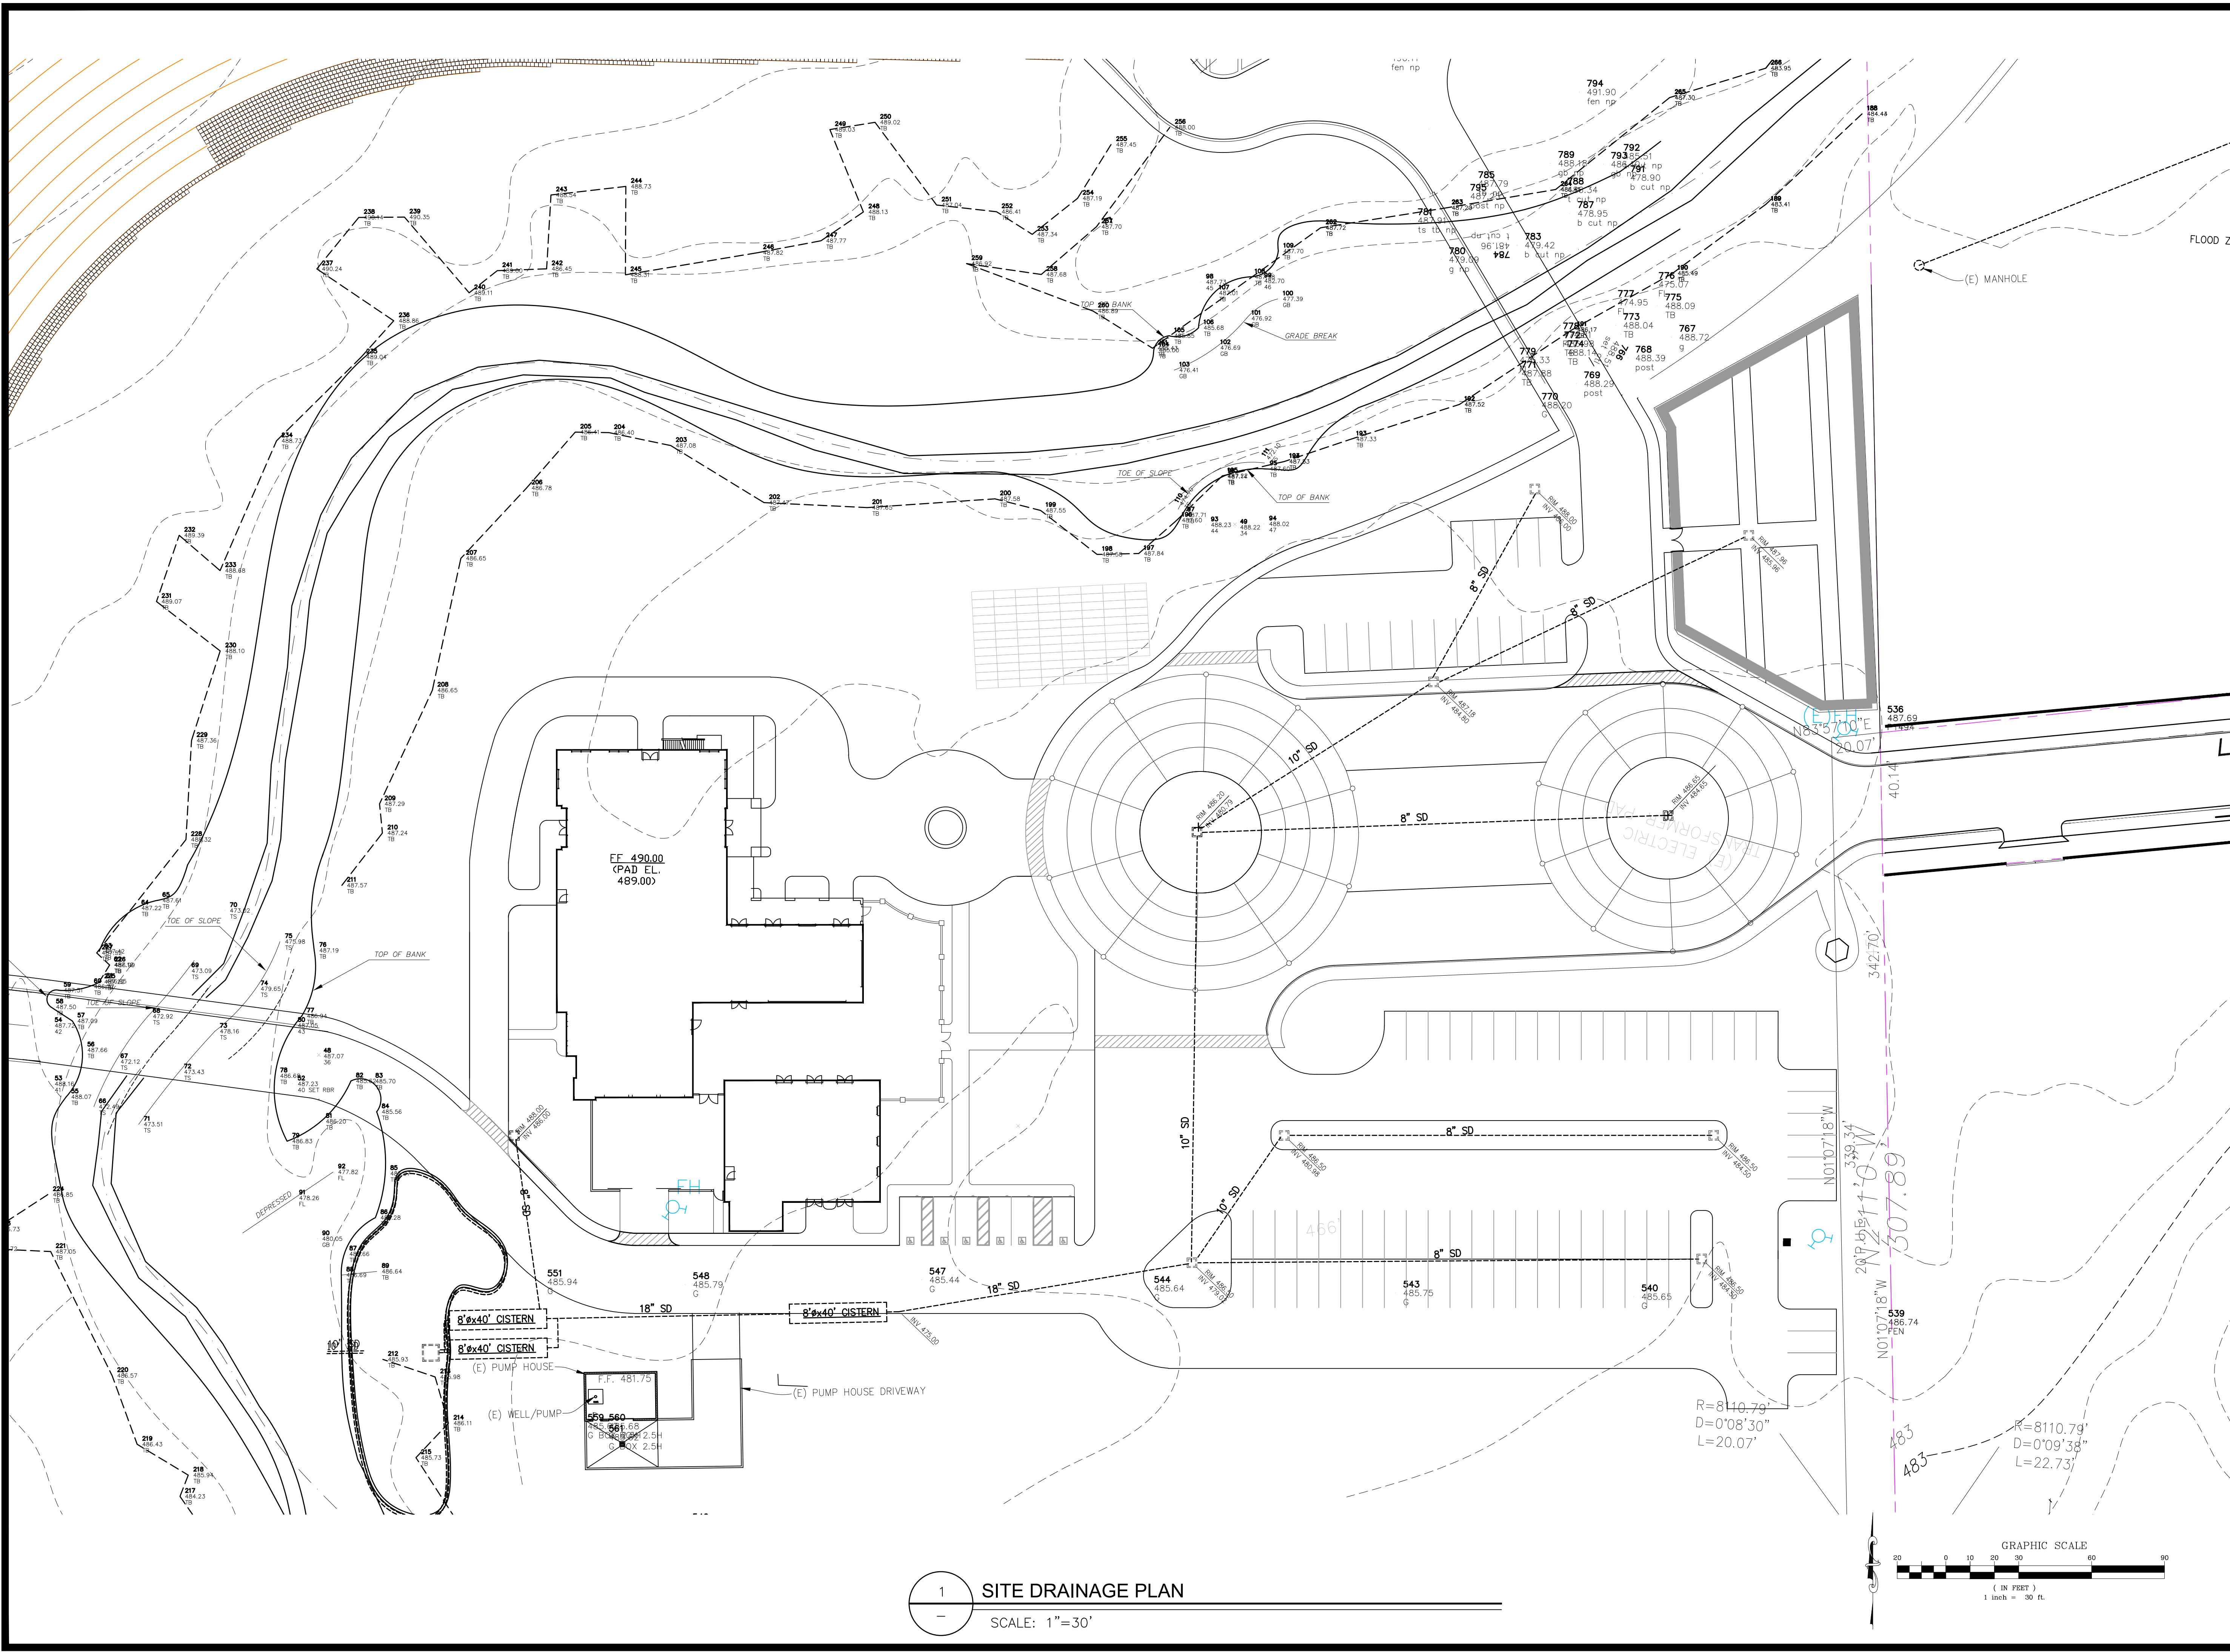

1 SITE DRAINAGE PLAN
SCALE: 1"=30'

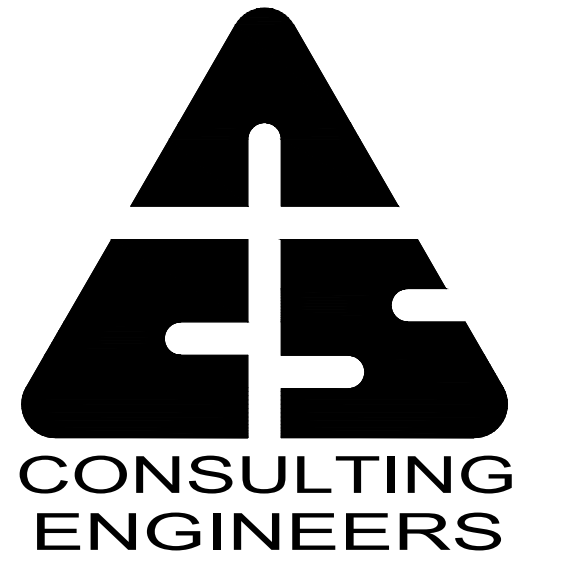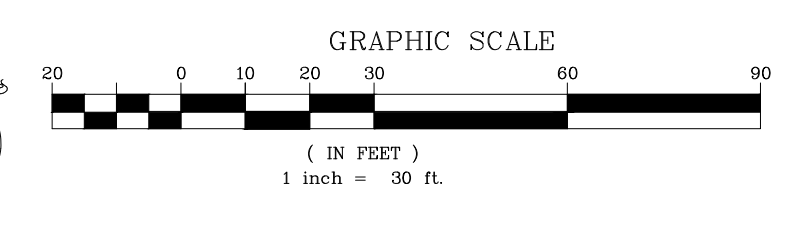

CONSULTING ENGINEERS
1124 E. 17th Street, #B
San Leandro, California 94577
Tel. (510) 645-1129
Fax (510) 645-1139



© 2018 ACS CONSULTING ENGINEERS

MONTE VISTA MEMORIAL GARDENS

APN 099-0015-016-03
3656 LAS COLINAS RD.
LIVERMORE, CA 94551

DRAWN BY	CHECKED BY	
VIT	JPA	
NO.	DATE	ISSUE
	05/05/2018	REVIEW SET

SHEET TITLE
SITE DRAINAGE PLAN

SHEET NUMBER
C-3.0

ACS JOB NO.: 18-19026

